




GAYLORD
NATIONAL®

RESORT & CONVENTION CENTER

on the Potomac

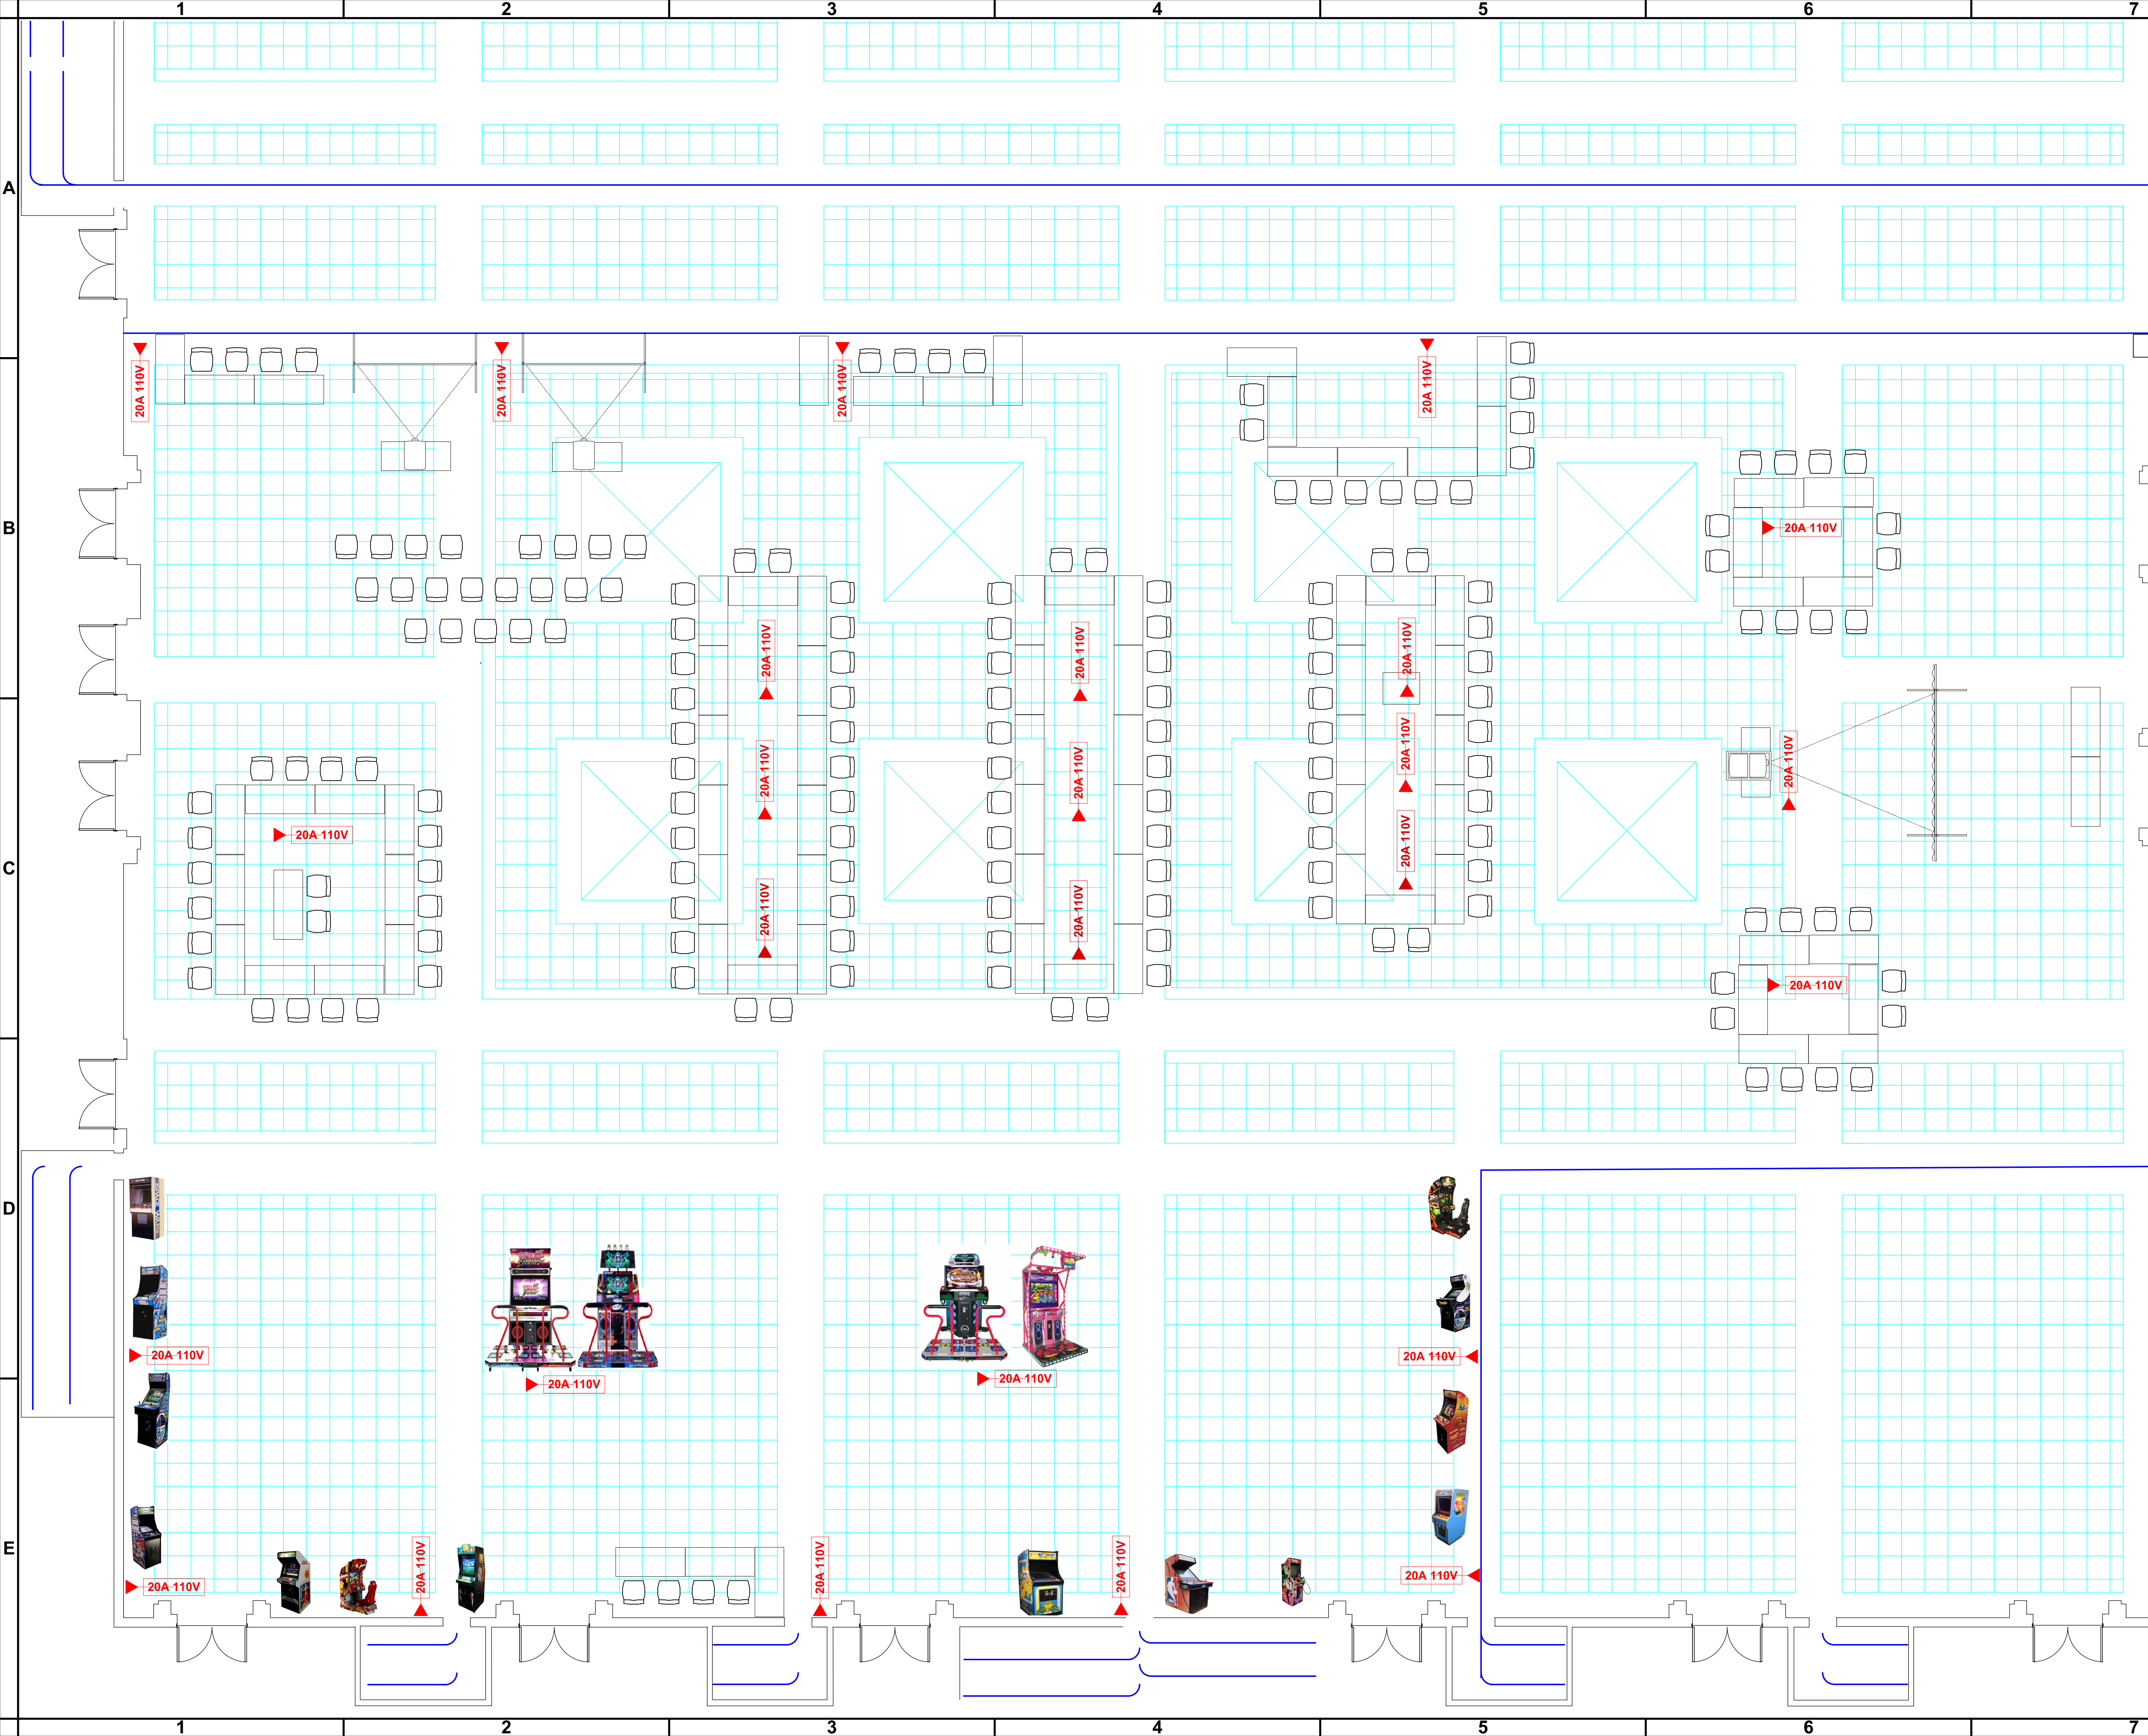

Production Title
**KATSUCON 2016
POTOMAC BALLROOM
C,D,1,2,3,4**

Drawing Title
**POWER FLOOR PLAN
GAMING ROOMS
POWER LAYOUT**

Designer
JASON "TOECUTTER" OLSON

Director
JOHN DUNCAN JR

Drawn By
JASON "TOECUTTER" OLSON

Scale
1:50 ARCH E

Venue
GAYLORD NATIONAL

Date
12/9/2015

CAD File Name
KATSUCON POWER MNGMT.vwx

2

of

2